


Plotted: 02/28/11 - 4:10 PM, By: glally
File: M:\Cranford\Jobs\Gabel Associates\025261000000\Drawings\Finals\100000-08E-SP-29-33- CCM.dwg, ----> SCC



STUDENT COMMUNITY CENTER
136.62 kW PHOTOVOLTAIC SYSTEM
594 PHOTOVOLTAIC MODULES

LEGEND

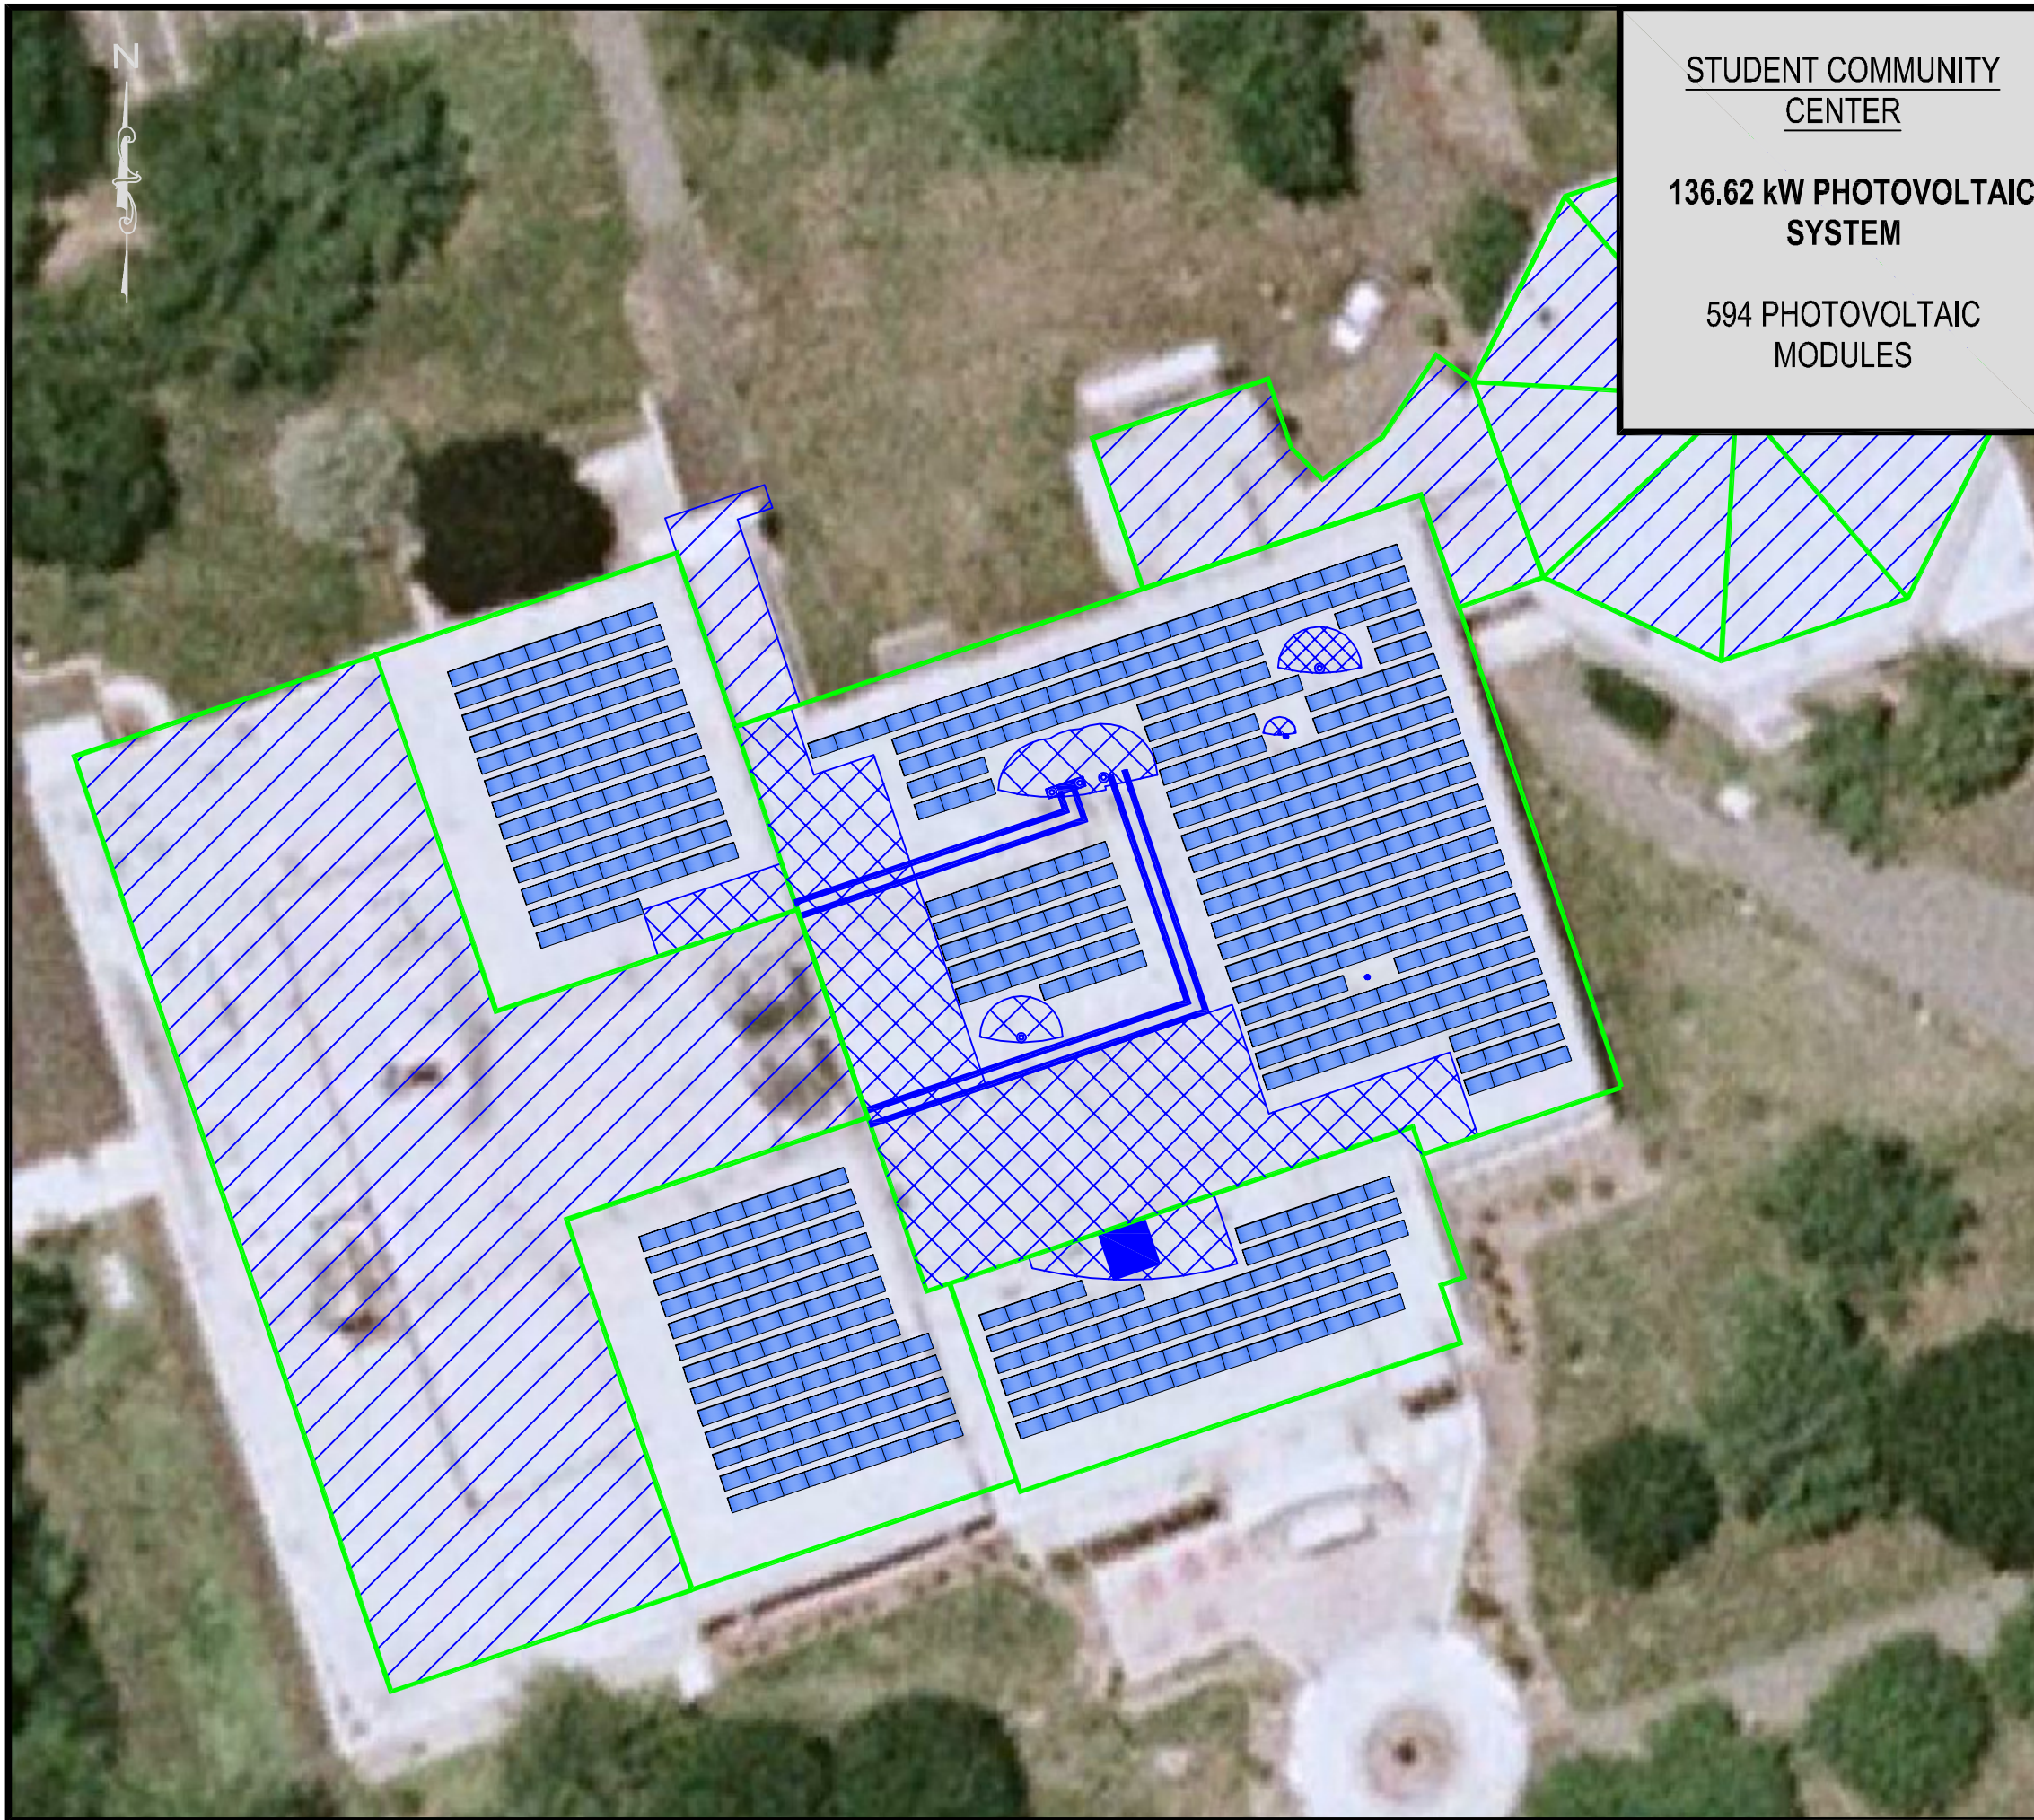




-  -PHOTOVOLTAIC MODULE ARRAY.
-  -ROOF AREA OUTLINE.
-  -ROOF OBSTRUCTIONS.
-  -UNUSED ROOF AREA.
-  -SHADED AREA.



PHOTO SOURCE - © 2010 BIRDSALL SERVICES GROUP

IMAGE BY GOOGLE EARTH ©

COUNTY COLLEGE OF MORRIS
STUDENT COMMUNITY CENTER
214 CENTER GROVE ROAD

PHOTOVOLTAIC CONCEPTUAL SITE PLAN

SITUATED IN
RANDOLPH, NEW JERSEY

 **BIRDSALL SERVICES GROUP**
ENGINEERS & CONSULTANTS

65 Jackson Drive
Cranford, NJ 07016
NJ Certificate of Authorization No. 24GA28028000

Tel.: 908.497.8900
Fax.: 908.497.9134
WWW.BIRDSALL.COM

Drawing Name: 100000-08E-SP-29-33- CCM.dwg	Drawn PTO	Designed	Checked GL	Released -
Job No. 100000	Date 12/20/2010	Scale: (H) NONE (V)	SP-33	