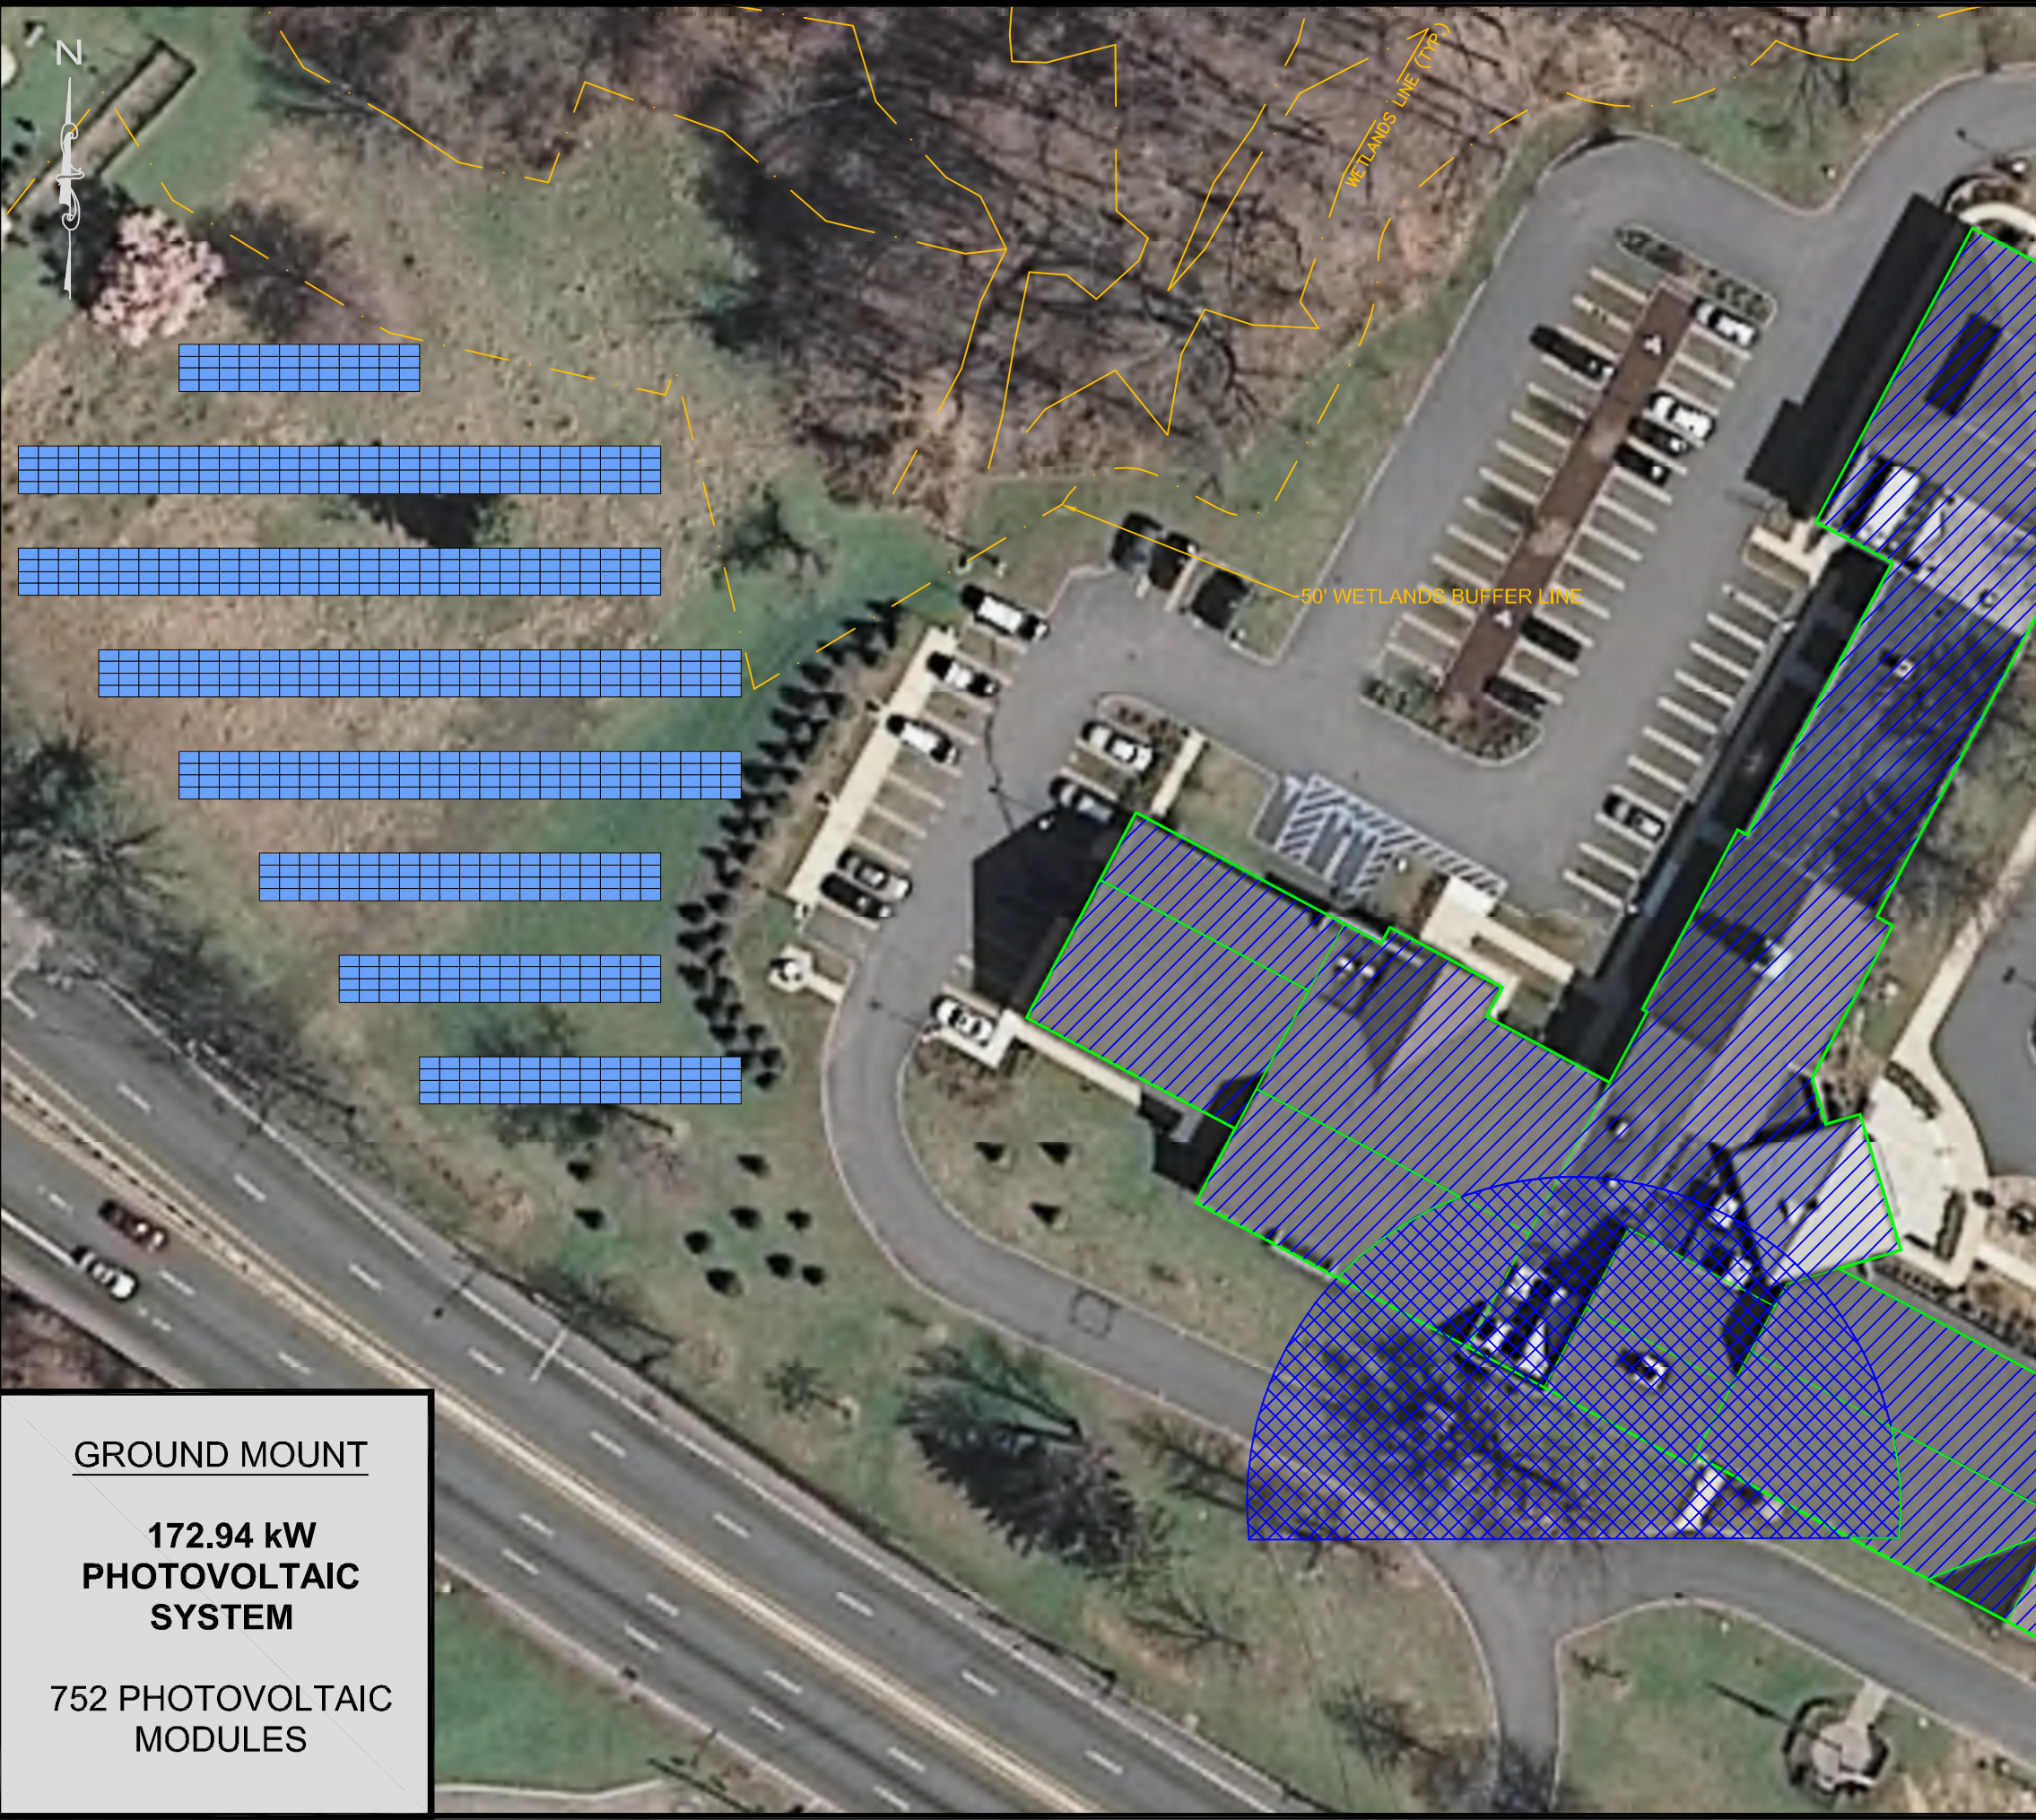


Plotted: 05/24/11 - 4:44 PM, By: glally
 File: M:\Cranford\Jobs\Gabel Associates\02526100000\Dwg\Finals\100000-08E-SP-1- Hanover Municipal Building.dwg, ----> ROOF



LEGEND

 

 
 
-  -PHOTOVOLTAIC MODULE ARRAY(GROUND).
-  -ROOF AREA OUTLINE.
-  -UNUSED ROOF AREA.
-  -SHADED AREA.



PHOTO SOURCE - © 2010 BIRDSALL SERVICES GROUP

NOTE: REMOVING TREES WILL INCREASE KW

IMAGE BY GOOGLE EARTH ©

**TOWNSHIP OF HANOVER
 MUNICIPAL BUILDING
 1000 STATE ROUTE 10**

PHOTOVOLTAIC CONCEPTUAL SITE PLAN

SITUATED IN
 WHIPPANY, NJ



65 Jackson Drive
 Cranford, NJ 07016
 NJ Certificate of Authorization No. 24GA28028000
 Tel.: 908.497.8900
 Fax.: 908.497.9134
 WWW.BIRDSALL.COM

GROUND MOUNT
172.94 kW
PHOTOVOLTAIC
SYSTEM
752 PHOTOVOLTAIC
MODULES

Drawing Name: 100000-08E-SP-1- Hanover Municipal Building.dwg	Drawn RFD	Designed	Checked GL	Released -
Job No. 100000	Date 02/08/2011	Scale: (H) NONE (V)	SP-1	