


Plotted: 03/03/11 - 11:17 AM. By: gally  
 File: \\bgsinc.wan\corp\Cranford\Jobs\Gabel Associates\02526100000\Drawings\Finals\100000-08E-SP-2- Parsippany Troy Hills Library 030111.dwg, ---> ROOF

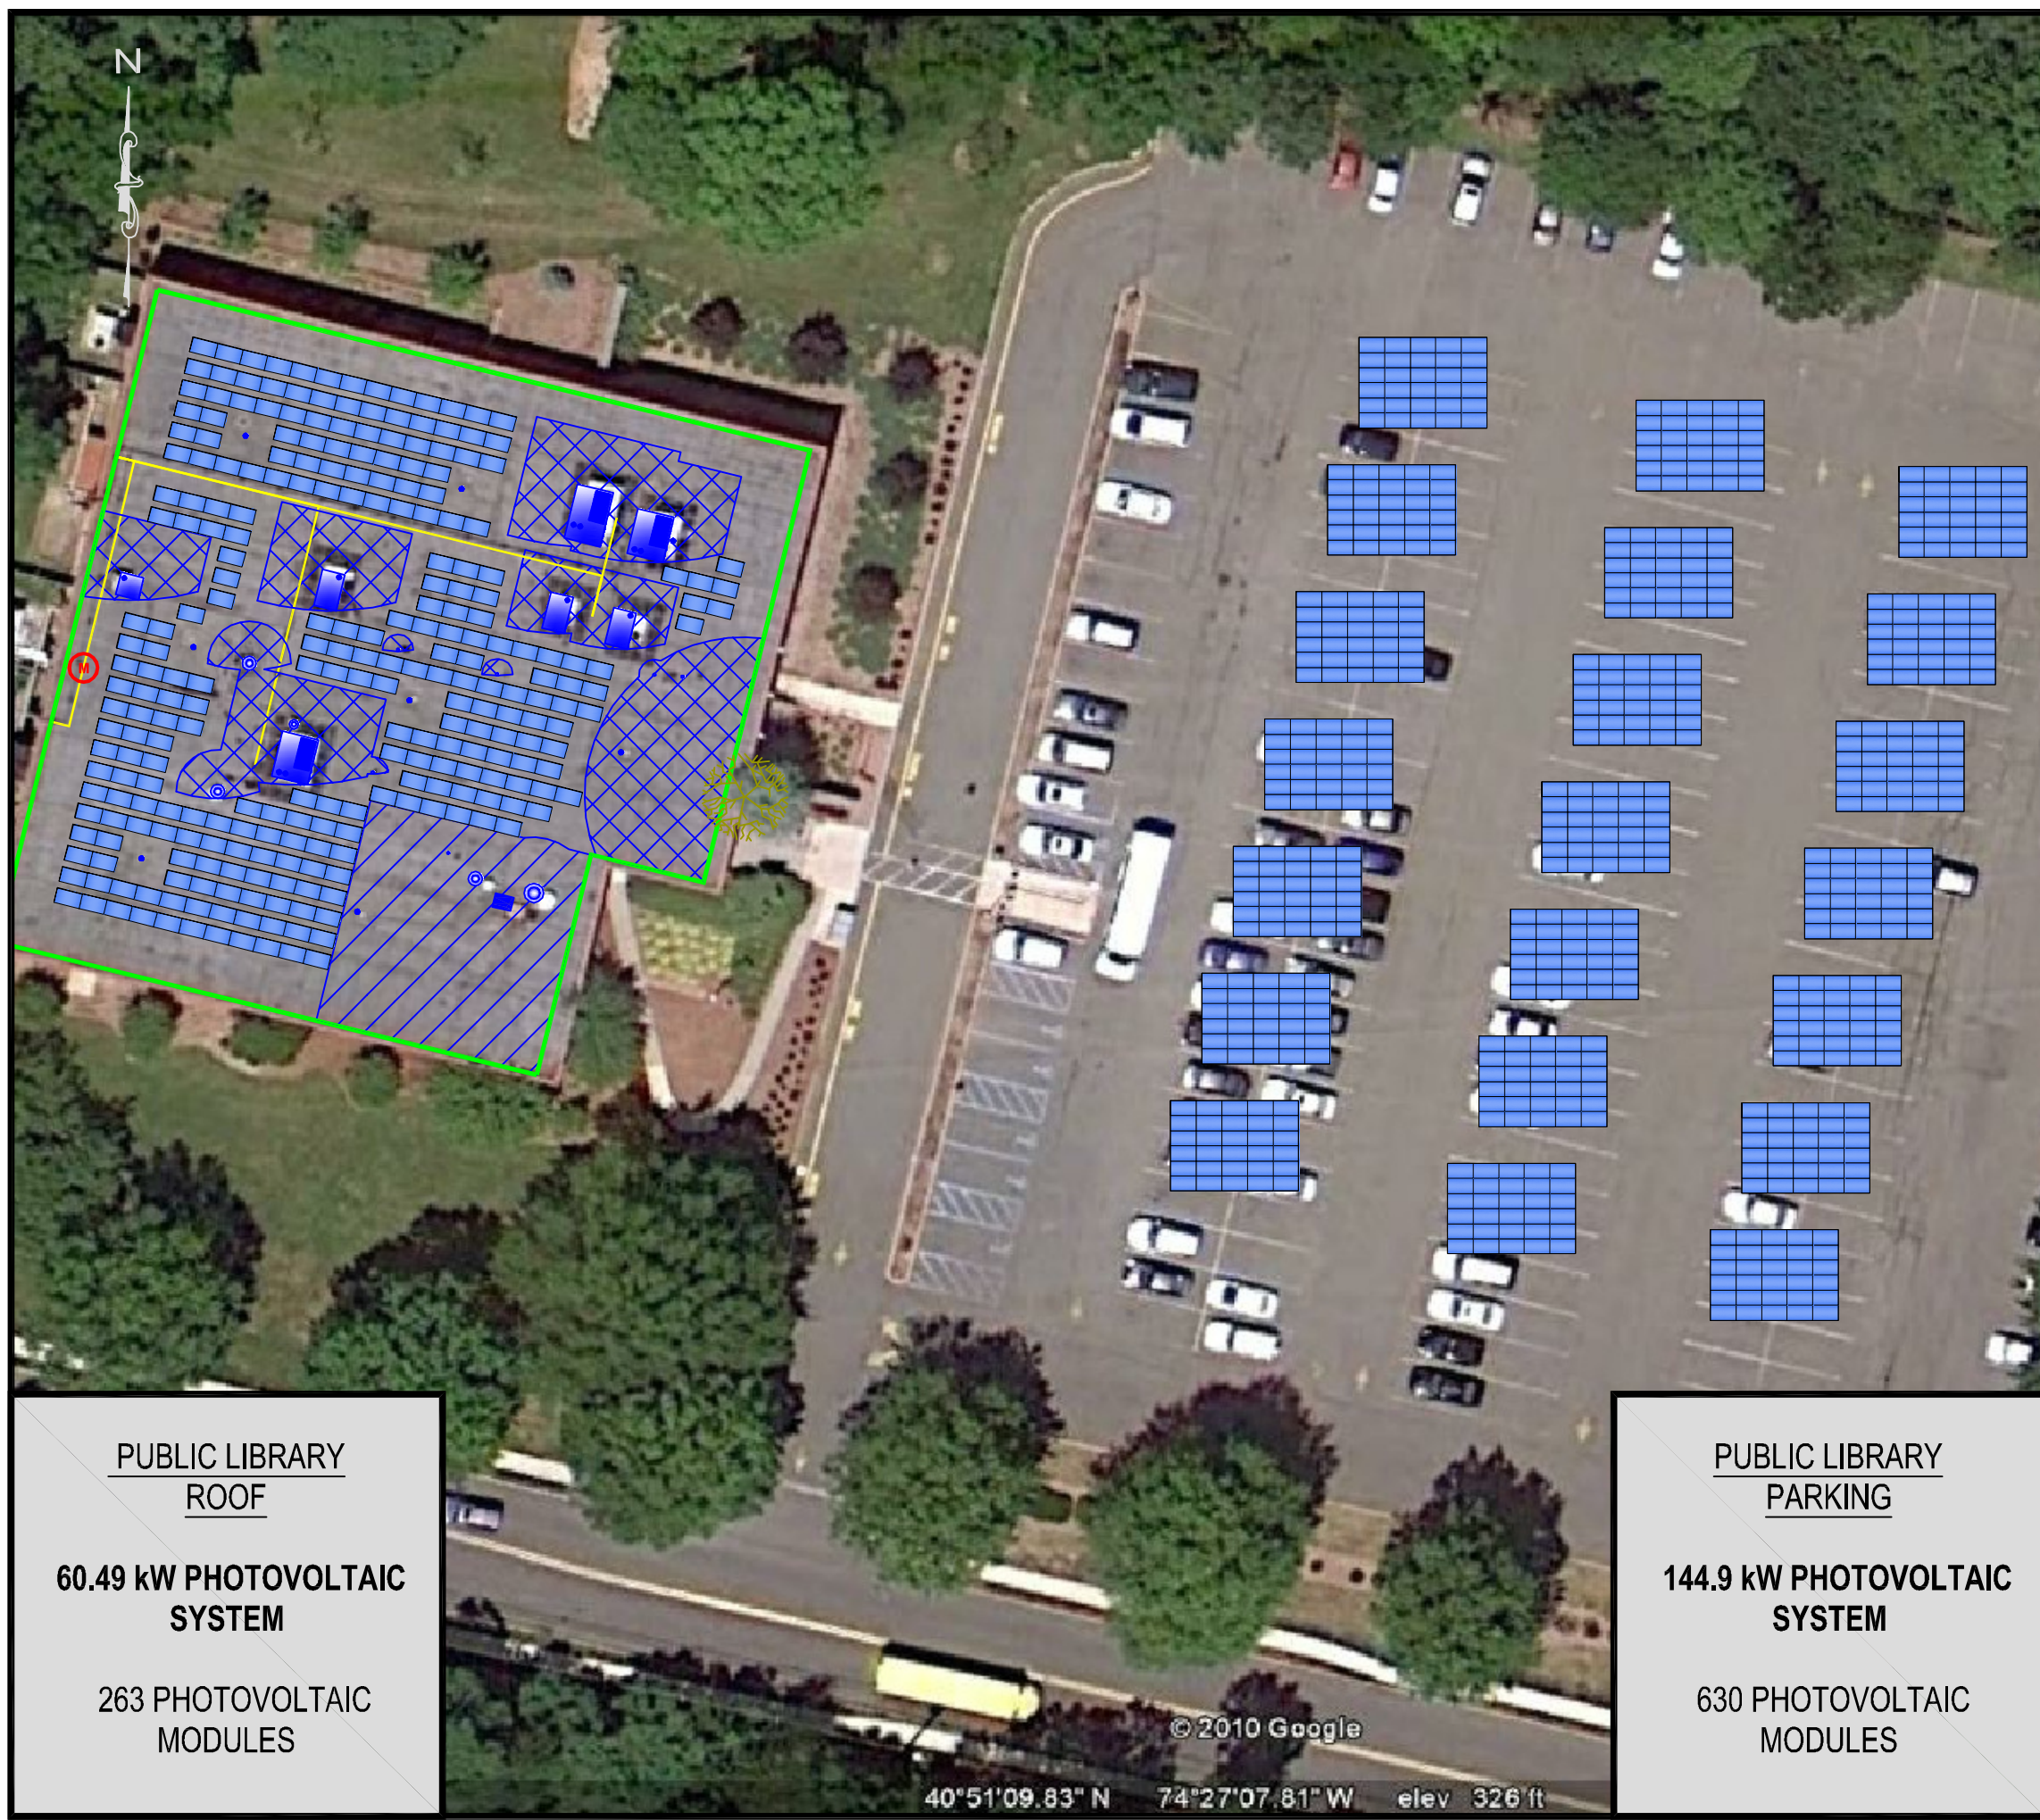

**LEGEND**

- PHOTOVOLTAIC MODULE ARRAY(ROOF).
- PHOTOVOLTAIC MODULE ARRAY(GROUND).
- ELECTRIC METER.
- ROOF AREA OUTLINE.
- ROOF OBSTRUCTIONS.
- UNUSED ROOF AREA.
- SHADED AREA.



PHOTO SOURCE - © 2010 BIRDSALL SERVICES GROUP

IMAGE BY GOOGLE EARTH ©

**TOWNSHIP OF PARSIPPANY-TROY HILLS**  
**PARSIPPANY-TROY HILLS PUBLIC LIBRARY**  
 449 HALSEY ROAD

**PHOTOVOLTAIC CONCEPTUAL SITE PLAN**

SITUATED IN  
PARSIPPANY-TROY HILLS



65 Jackson Drive  
 Cranford, NJ 07016  
 NJ Certificate of Authorization No. 24GA28028000

Tel.: 908.497.8900  
 Fax.: 908.497.9134  
 WWW.BIRDSALL.COM

Drawing Name: 100000-08E-SP-2- Parsippany Troy Hills Library 030111.dwg		Drawn PTO	Designed	Checked GL	Released -
Job No. 100000	Date 02/16/2011	Scale: (H) NONE (V)		<b>SP-2</b>	

**PUBLIC LIBRARY**  
**ROOF**  
 60.49 kW PHOTOVOLTAIC  
 SYSTEM  
 263 PHOTOVOLTAIC  
 MODULES

**PUBLIC LIBRARY**  
**PARKING**  
 144.9 kW PHOTOVOLTAIC  
 SYSTEM  
 630 PHOTOVOLTAIC  
 MODULES

© 2010 Google  
40°51'09.83" N 74°27'07.81" W elev 326 ft